



Stockheim ♥ Haberschlacht ♥ Niederhofen ♥ Kleingartach ♥ Hardheim

**WINNING THE PEACE WITH PEACE THROUGH
VIGILANCE • STRENGTH • HONOR • RESOLVE**

Charlie Battery Original Site Plan

This Charlie Battery Original Site plan came to us by way of Thomas Schulz, our Military Historian Kamerad near Heilbronn, De. It is another in the series of incredibly unique Charlie Battery historical documents that he has provided us, and again, we are very grateful for his ongoing interest in our project.


This document was presented in a jpg file format, and is seen here in that original given size, minus the unnecessary bits that I cropped out, which also allowed me to make each page the same size.


I could have made the page size smaller, however, because it is of such a low resolution trying to zoom in on any given section would have only produced an unreadable image. So I went with this large size. Also, someone might want to print it out, and this size allows for the best possible results in that effort.

The first Site plan page is an overall view, with the remaining pages being close-ups of the original. Web browsers are now coming with the ability view pdf's in a tab, however, all of the pdf's made for this website were created for, and are best viewed, in Adobe Reader. Also, some of the pages that are horizontal need to be roatated to vertical to be read, which is another reason to use Adobe Reader. So if you want the best viewing experience use Adobe Reader.

Many thanks/vielmals Thomas...!



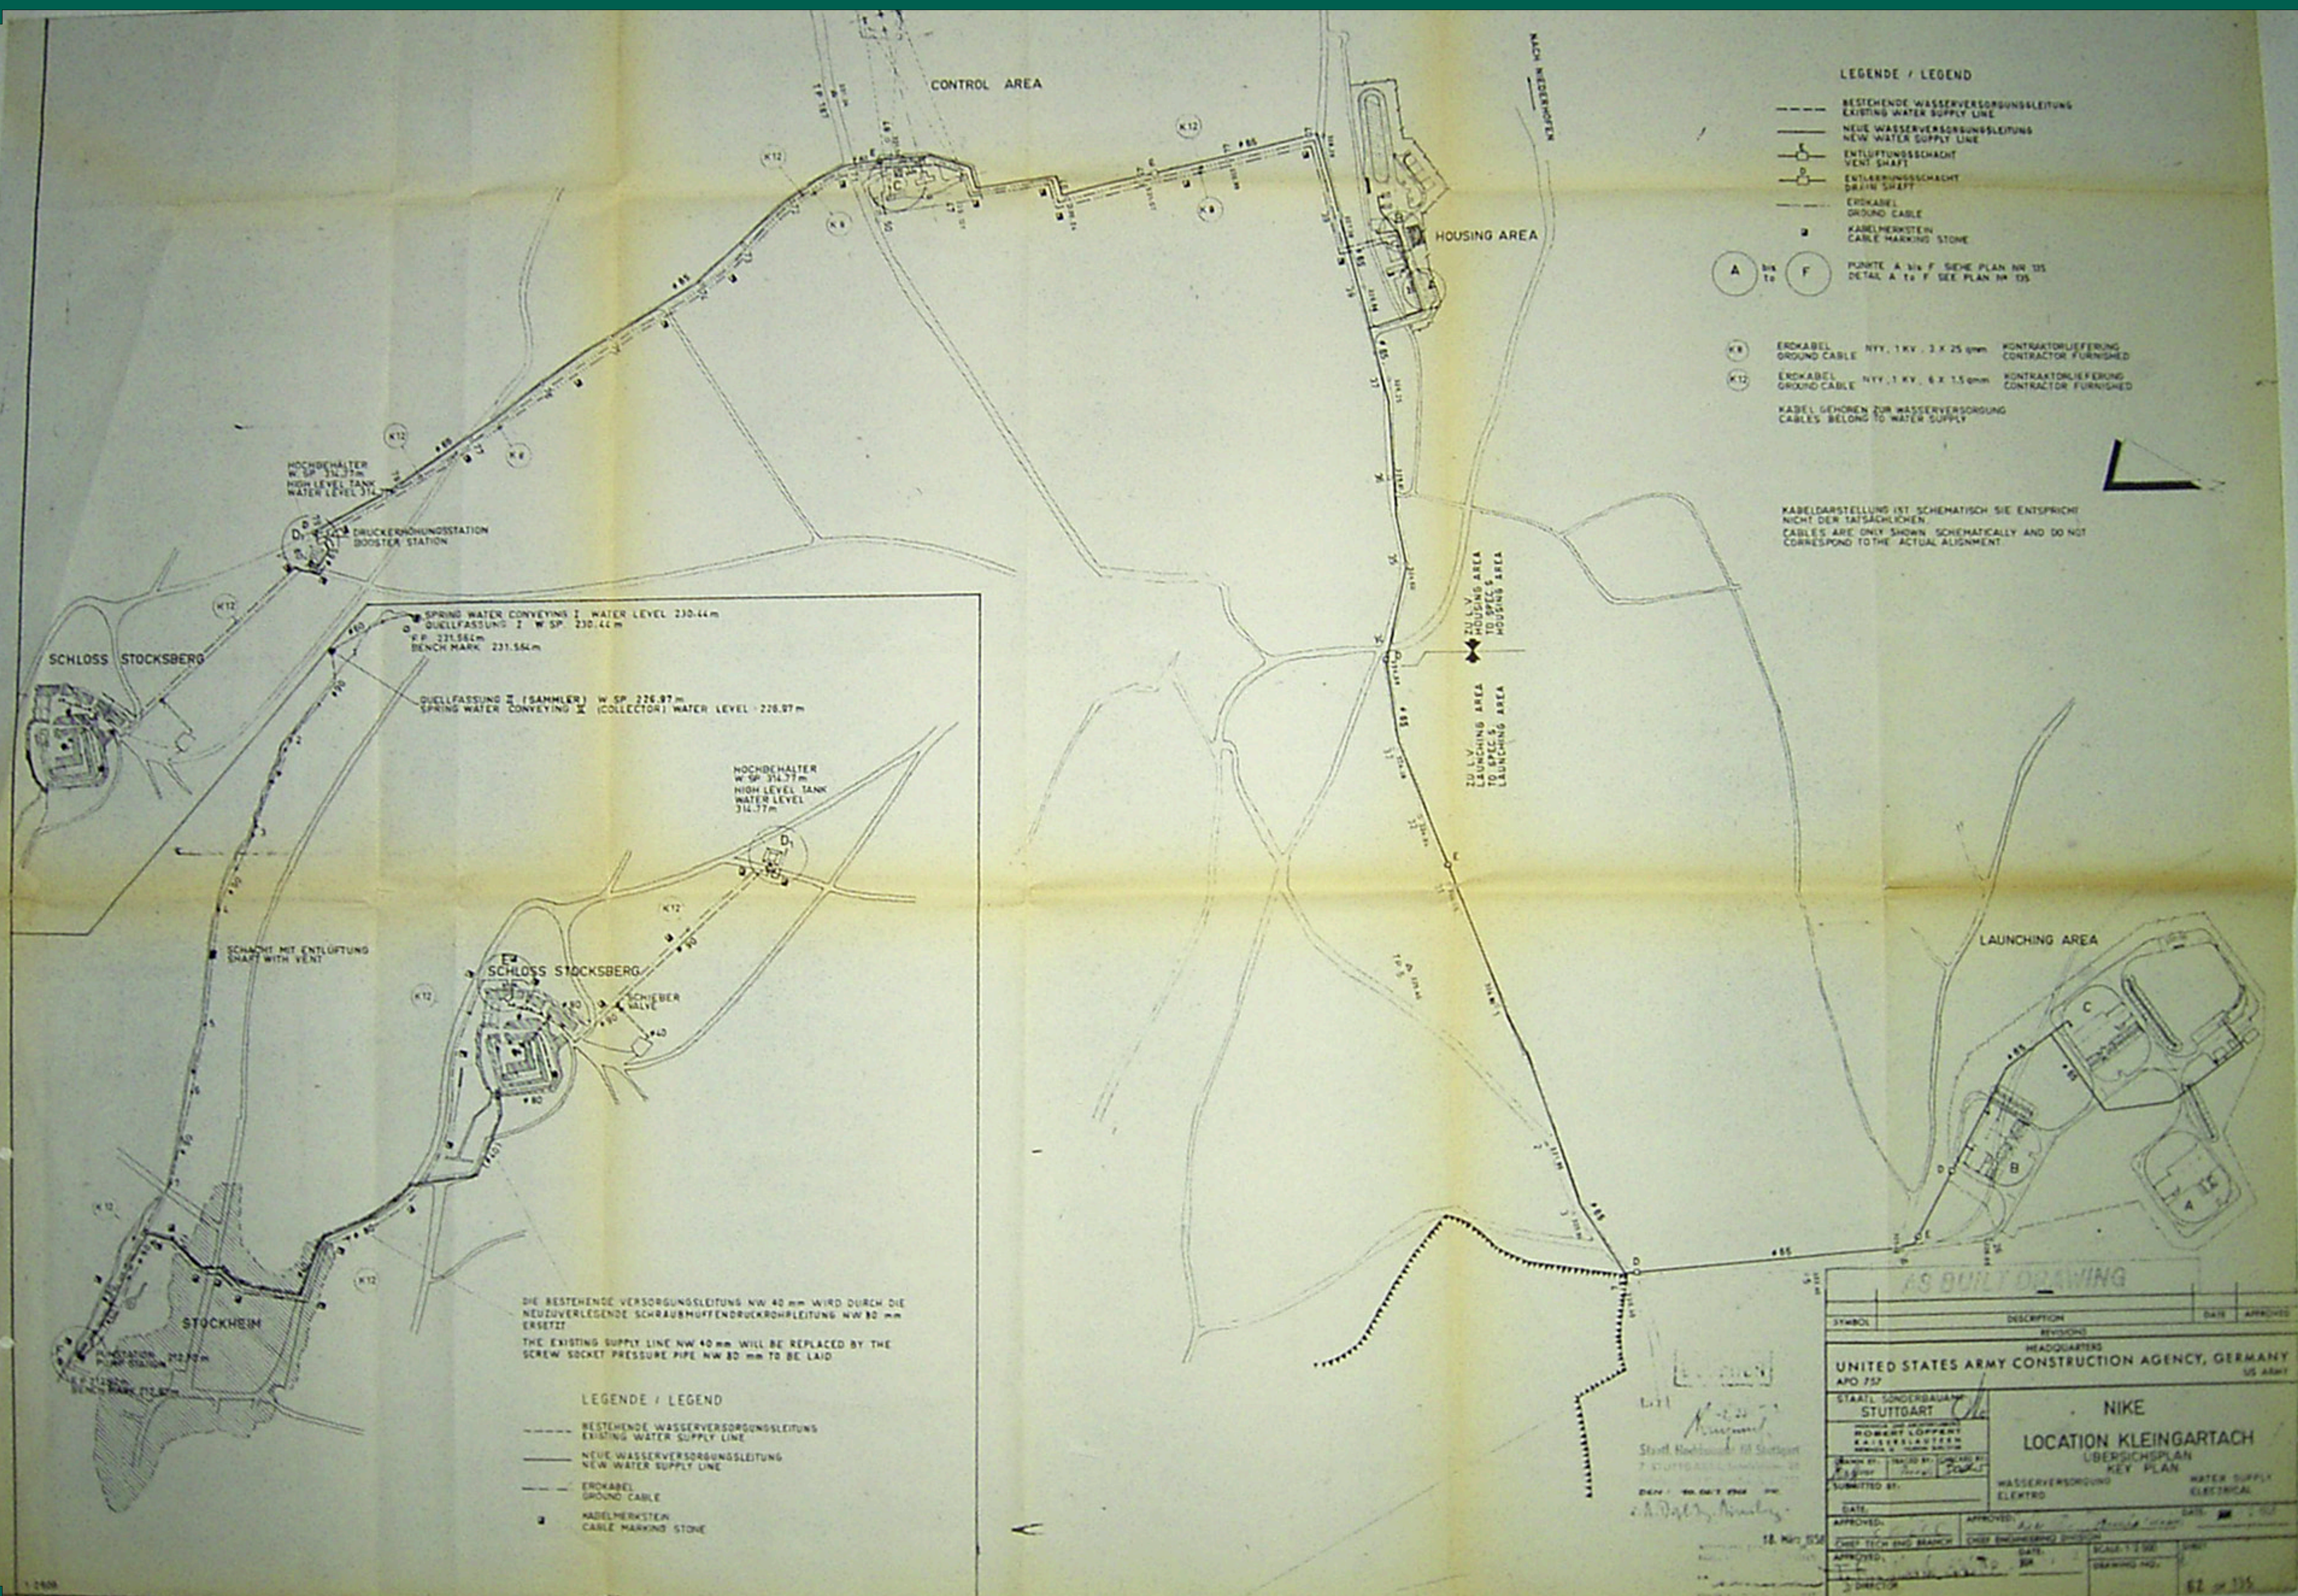

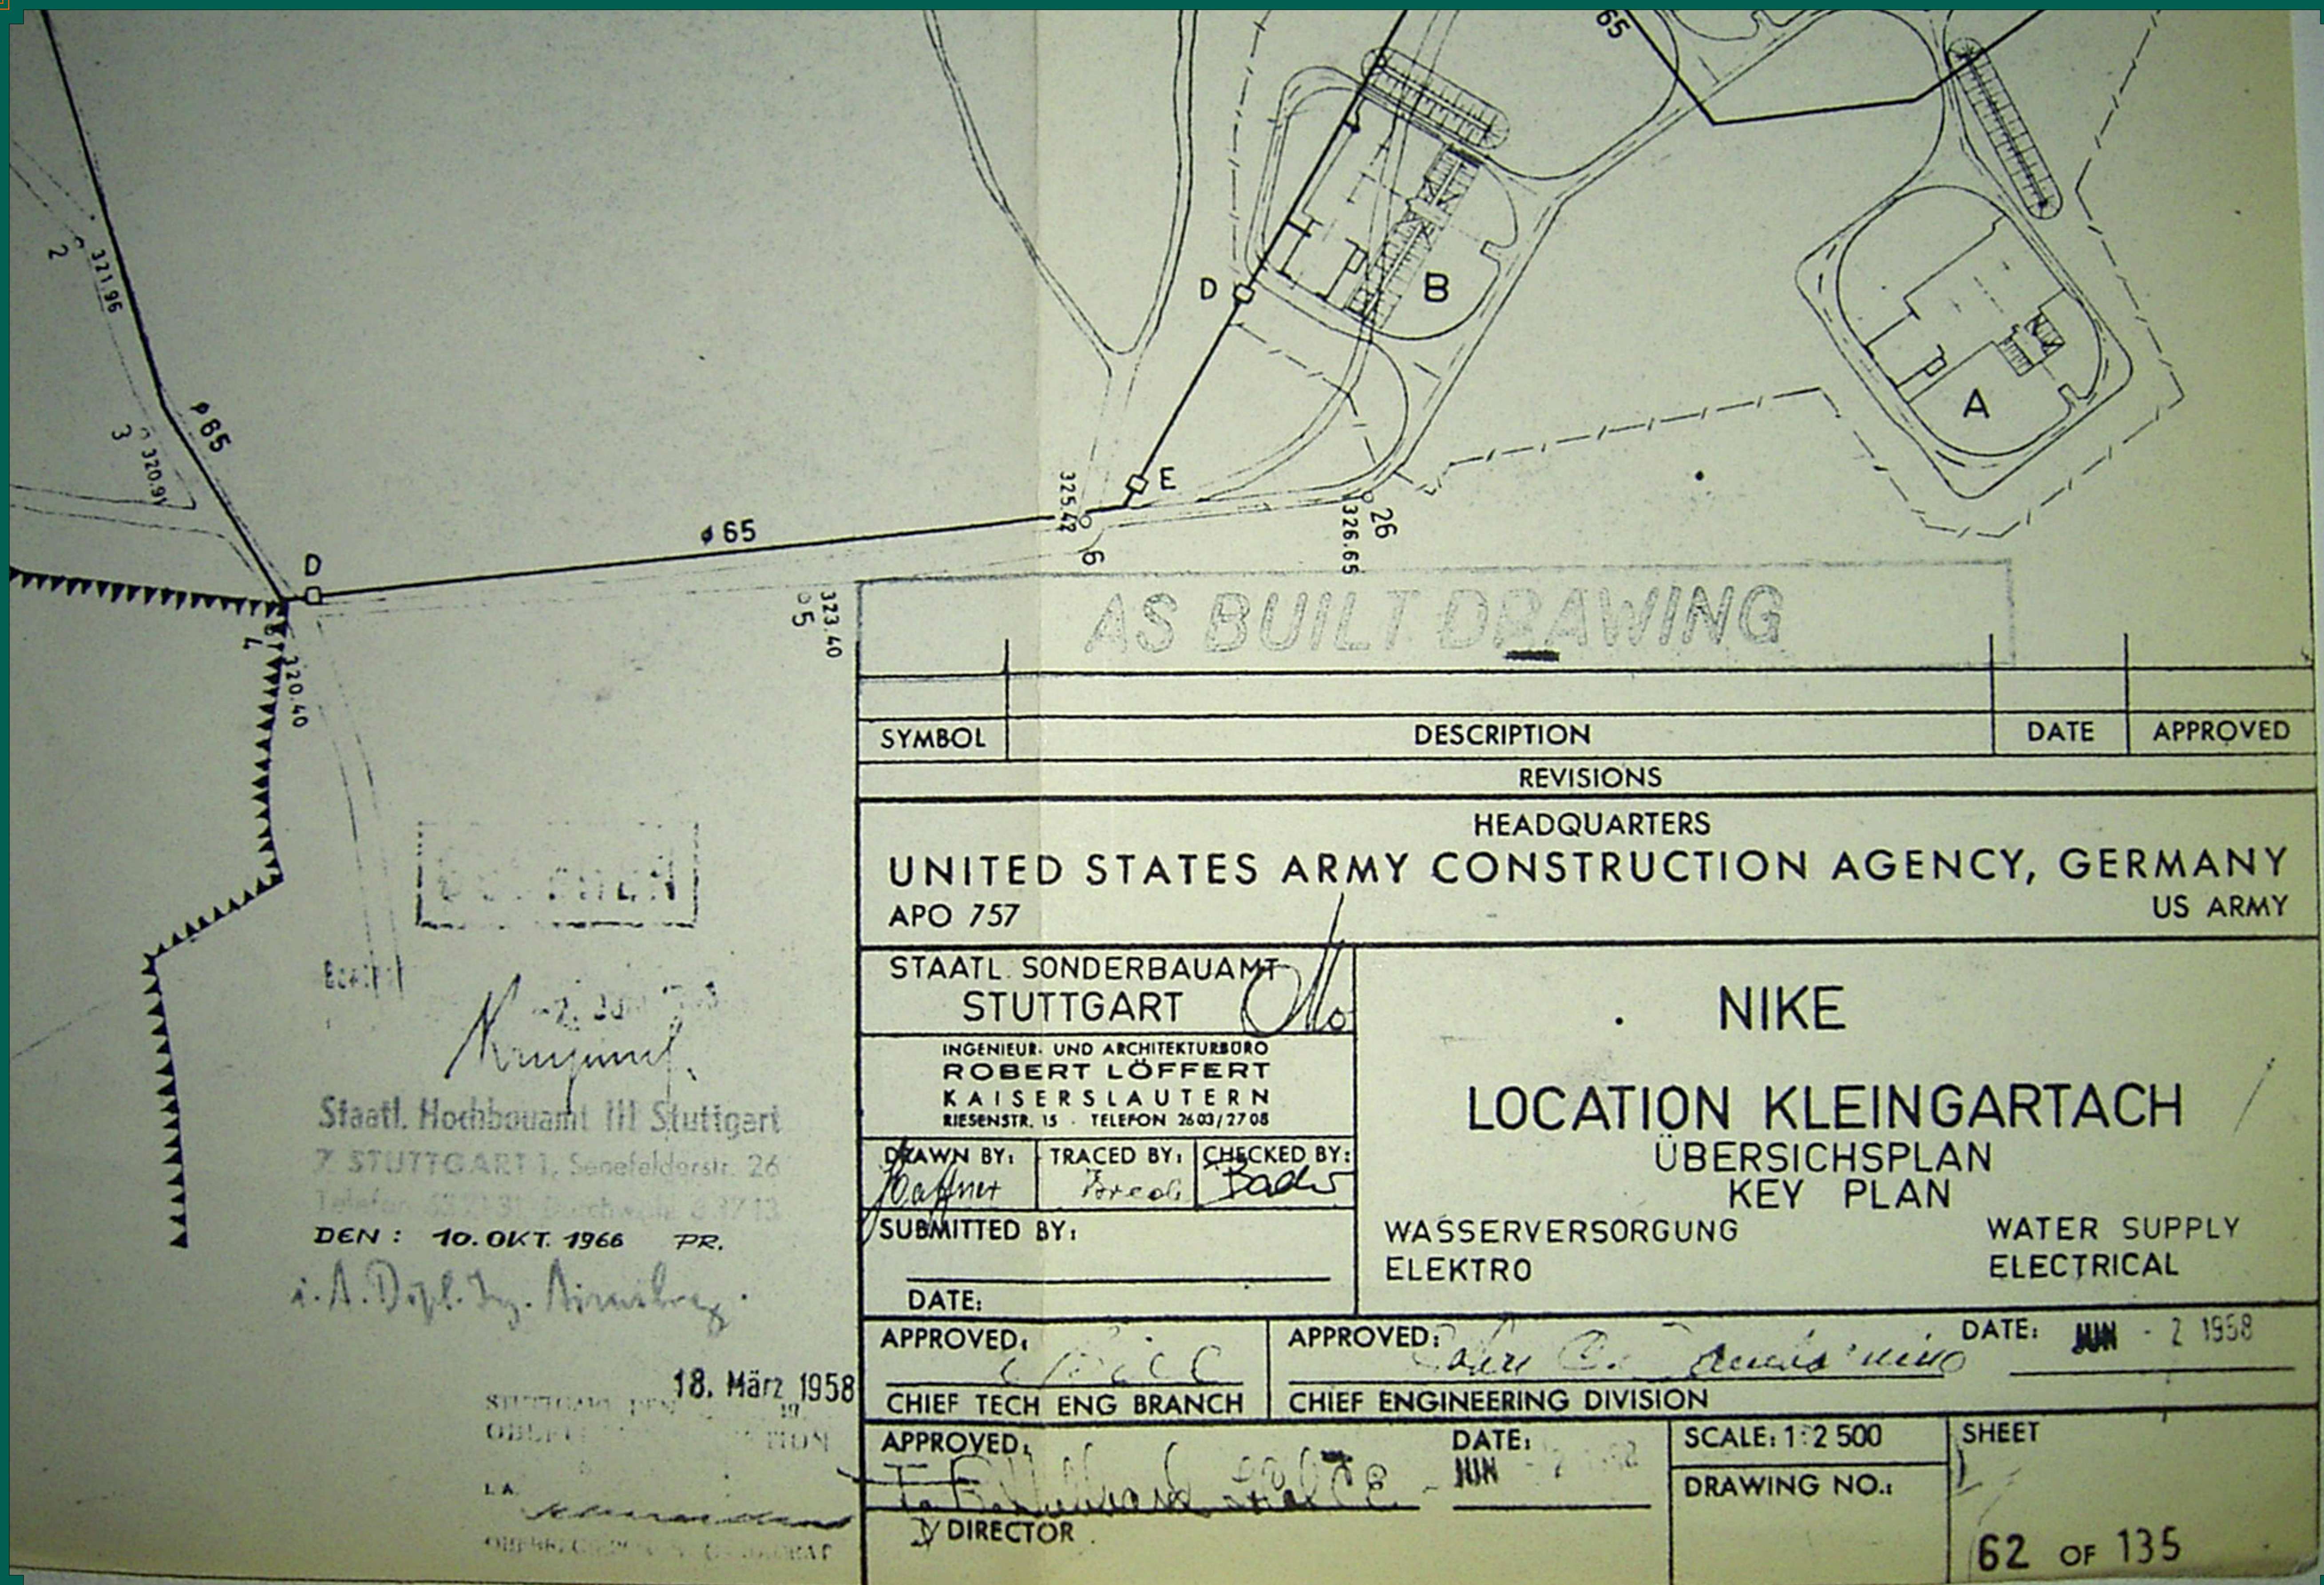

AS BUILT DRAWING

SYMBOL

DESCRIPTION

DATE

APPROVED

REVISIONS

HEADQUARTERS

UNITED STATES ARMY CONSTRUCTION AGENCY, GERMANY
APO 757 US ARMY

STAATL. SONDERBAUAMT
STUTTGART

INGENIEUR- UND ARCHITEKTURBÜRO
ROBERT LÖFFERT
KAISERSLAUTERN
RIESENSTR. 15 - TELEFON 2603/2708

NIKE

LOCATION KLEINGARTACH
ÜBERSICHSPLAN
KEY PLAN

DRAWN BY: TRACED BY: CHECKED BY:

SUBMITTED BY:

WASSERVERSORGUNG
ELEKTRO

WATER SUPPLY
ELECTRICAL

DATE:

APPROVED:

APPROVED:

DATE: JUN - 2 1958

CHIEF TECH ENG BRANCH

CHIEF ENGINEERING DIVISION

APPROVED:

DATE:

SCALE: 1:2 500

SHEET

DRAWING NO.:


DIRECTOR

62 OF 135

Staatl. Hochbauamt III Stuttgart
7. STUTTGART 1, Senefelderstr. 26
Telefon 332131, Durchwahl 33713
DEN: 10. OKT. 1966 PR.

18. März 1958

STUTTGART 1, Senefelderstr. 26
OBJEKT: ...
L.A. ...
OBJEKT: ...

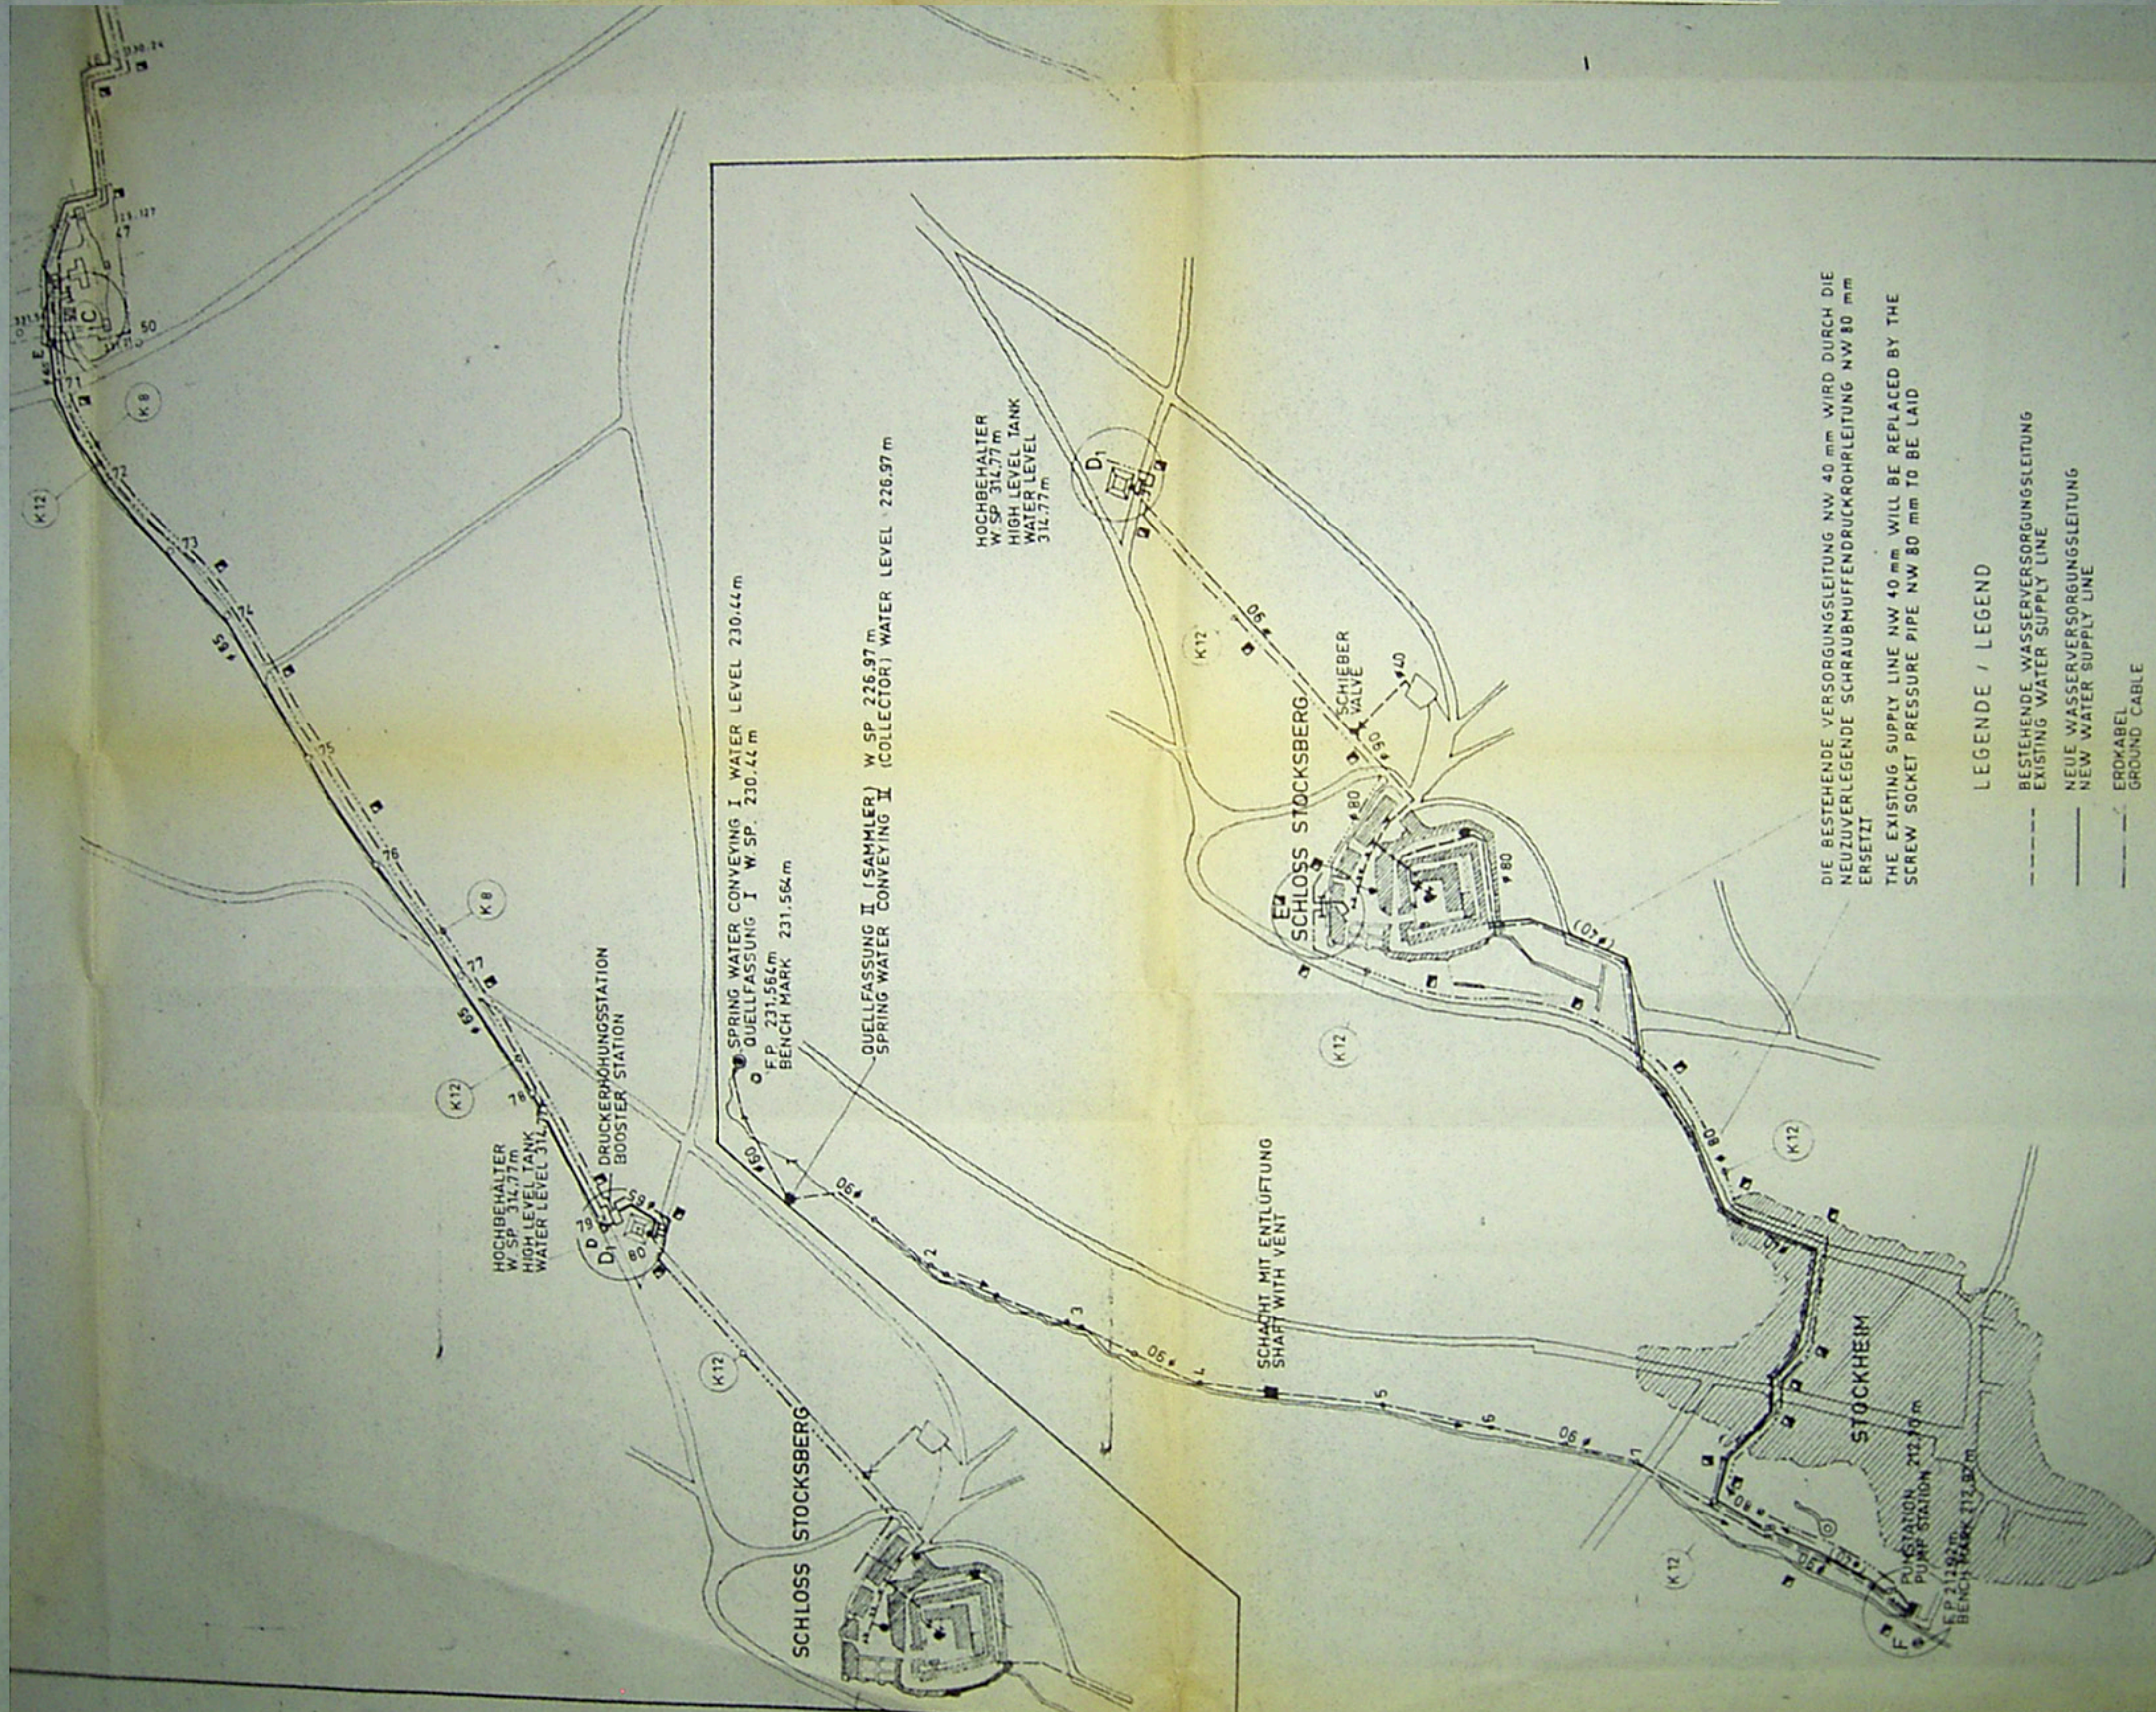

A
biz
to

7

PUNIKTE A bis F
DETAIL A bis F

天田


ERDKABEL NY, 1KV, 3
GROUND CABLE

K 12

ERDKABEL NY 1 KV, 6
GROUND CABLE

KABEL GEHOREN ZUR WASSER
CABLES BELONG TO WATER SI

KABELDARSTELLUNG IST SCHNITT DER TATSÄCHLICHEN. CABLES ARE ONLY SHOWN CORRESPOND TO THE ACTUAL

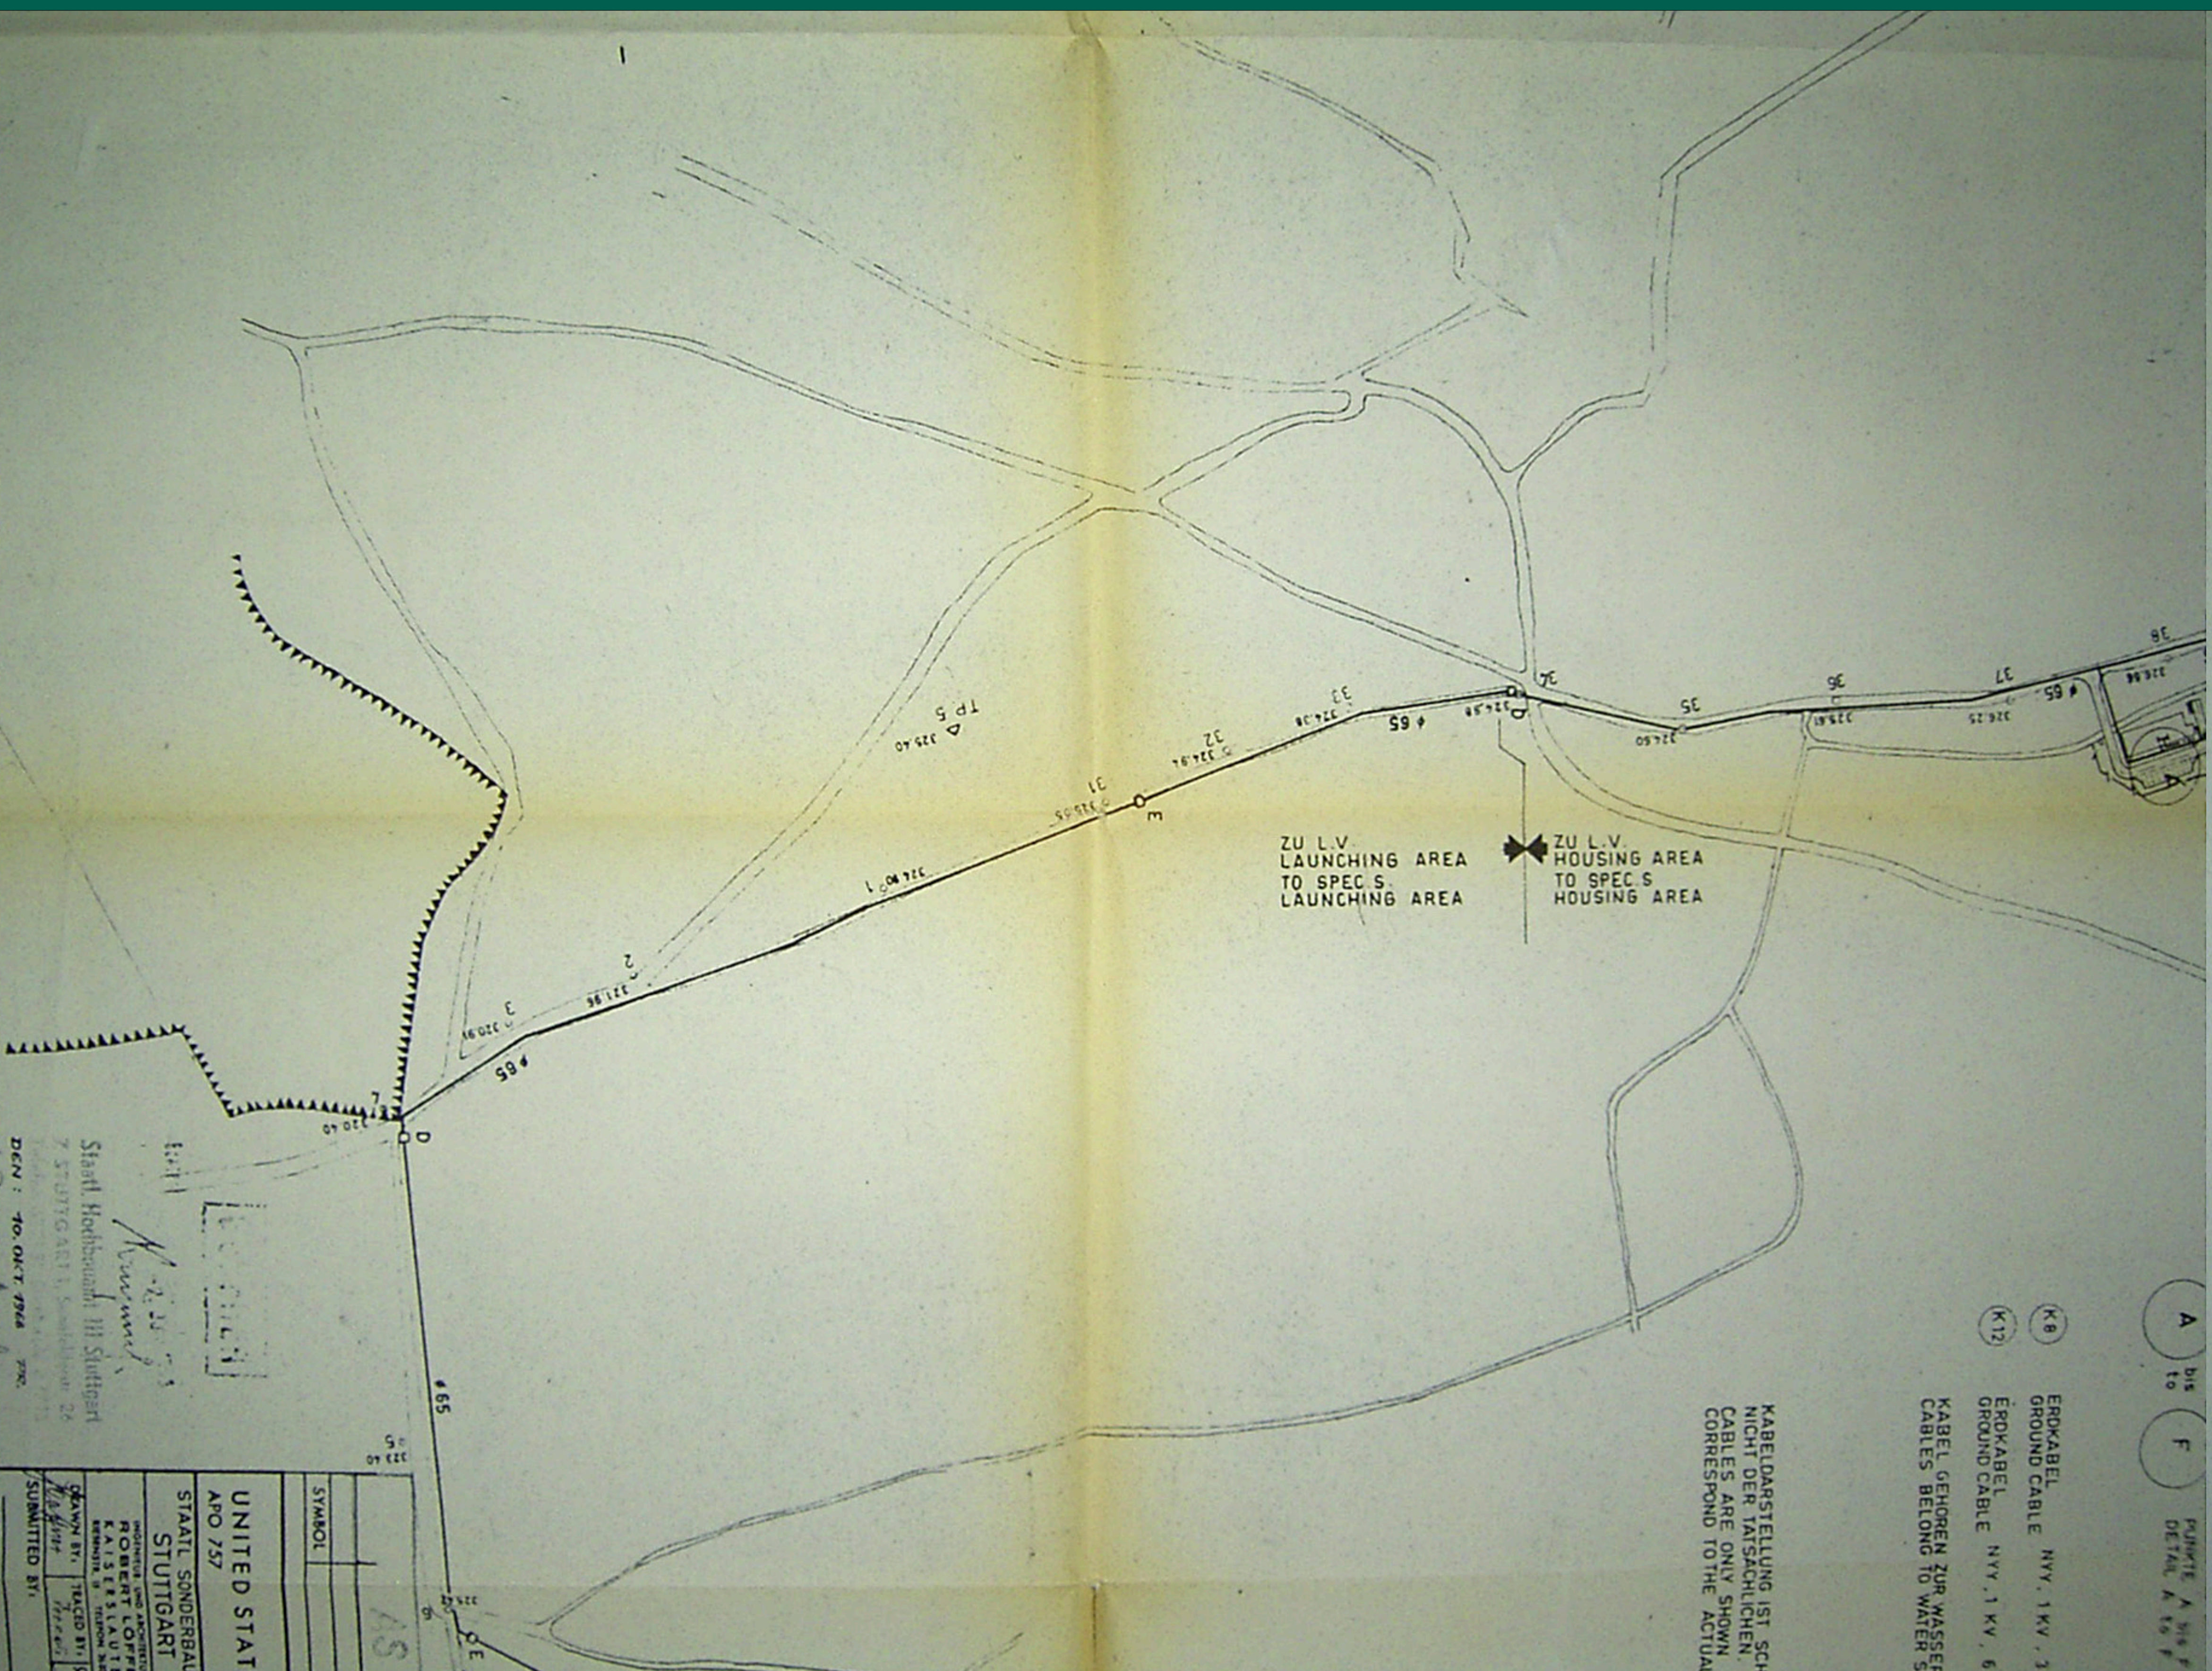

KABELDARSTELLUNG IST SCHEMATISCH, SIE ENTSPRICHT NICHT DER TATSÄCHLICHEN.
CABLES ARE ONLY SHOWN SCHEMATICALLY AND DO NOT CORRESPOND TO THE ACTUAL ALIGNMENT.

ZU L.V.
HOUSING AREA
TO SPEC'S
LAUNCHING AREA

ZU L.V.
LAUNCHING AREA
TO SPEC'S
LAUNCHING AREA

LAUNCHING AREA

AS BUILT DRAWING

UNITED STATES ARMY CONSTRUCTION AGENCY, GERMANY
US ARMY
APO 757

STAATL. SONDERBAUAMT
STUTTGART
HOCHBAU- UND ARCHITEKTURBÜRO
ROBERT LÖFFERT
KAISER-SLAUTERN
REINHARDT, 13. TELEFON 240/2758

DRAWN BY: *W. Hoffm.* TRACED BY: *Frederi* CHECKED BY: *Frederi*

SUBMITTED BY:

DATE:

APPROVED: *Frederi*
CHIEF TECH. ENG. BRANCH

APPROVED: *Frederi*
DIRECTOR

APPROVED: *Frederi*
CHIEF ENGINEERING DIVISION

DATE: JUN 1 1958

SCALE: 1:2 500
DRAWING NO. 1

62 OF 135

Staatl. Hochbauamt III Stuttgart
7. STUTTGART 1, Sonderbauamt 26
DEN: 10. OKT 1966 PR.
i.A. D. Dr. G. A. A. A.

18. März 1958

STUTTGART 1, Sonderbauamt 26
GUTGESEHEN
i.A. D. Dr. G. A. A. A.

NIKE
LOCATION KLEINGARTACH
ÜBERSICHTSPLAN
KEY PLAN
WASSERVERSORGUNG
ELEKTRO
WATER SUPPLY
ELECTRICAL

DATE: JUN 2 1958

SHEET

